


# A10 - Kitchen & Bath Remodel Electrical Plan


THIS DRAWING DEPICTS MINIMUM CODE REQUIREMENTS PER CRC INFORMATION IS FOR REFERENCE ONLY AND IS NOT A SUBSTITUTE FOR ACCURATE DRAWINGS PREPARED FOR EACH PROPOSED CONSTRUCTION PROJECT.

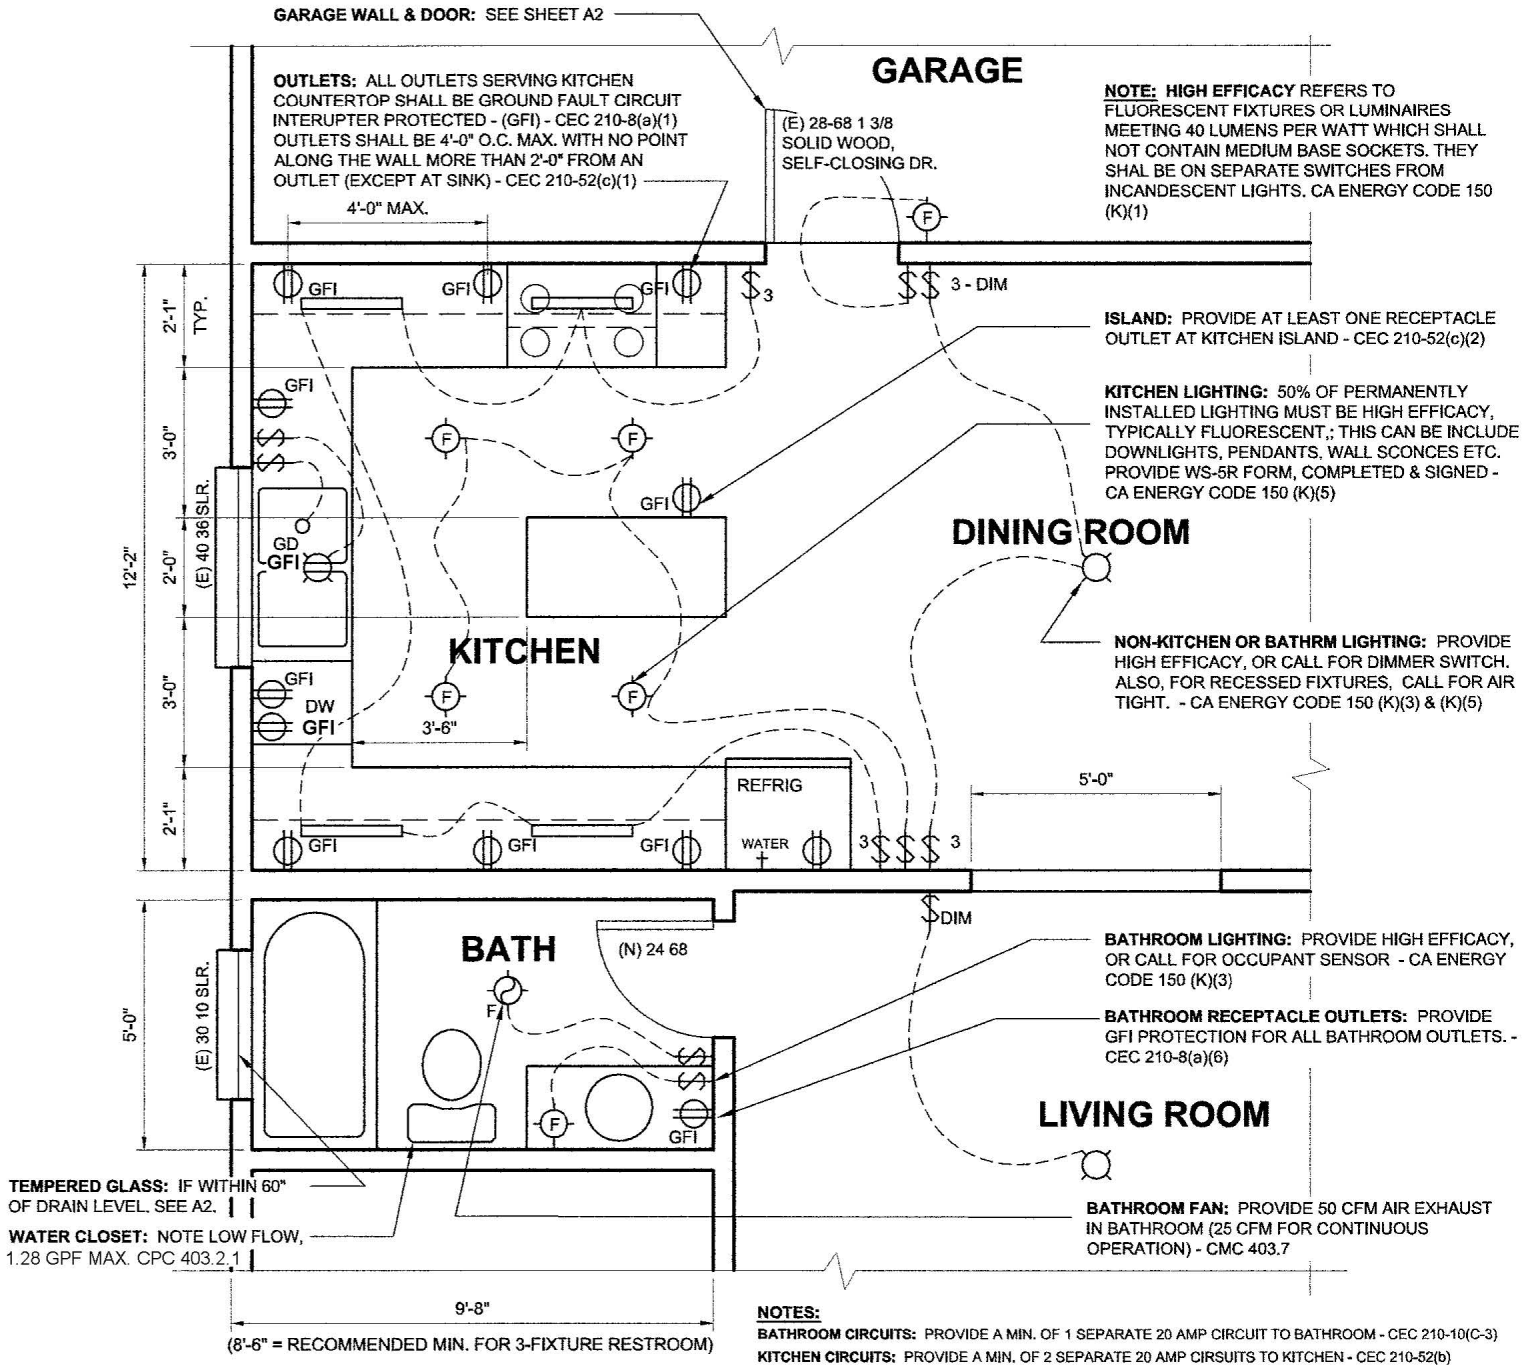

## FLOOR PLAN

**LEGEND:** FOR LARGER PROJECTS, PROVIDE COMPLETE LEGEND FOR ALL SYMBOLS.

**NOTE:** All new receptacles must be 'Tamper-Resistant' per CEC 406.11

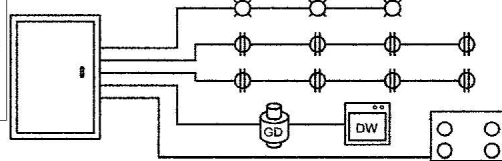

Provide Title Block. Leave margin on all sides.

This scale is for example only. Use 1/8" or 1/4" = 1'-0". Typical min. sheet size is 11" x 17" (8 1/2" X 11" for small projects.)

NAME, ADDRESS AND PHONE NO. OF DESIGNER  
 XXX XXX XXX XXX  
 XXX XXX XXX XXX

WET SIGNATURE OF DESIGNER ON EACH SHEET  
 (AND PROFESSIONAL STAMP IF APPLICABLE)

**EXAMPLE  
 RESIDENCE**

**PLAN**

SAMPLE DRAWING

SCALE: 1/4" = 1'-0"  
 DATE:

SHEET NO.  
**A10**